


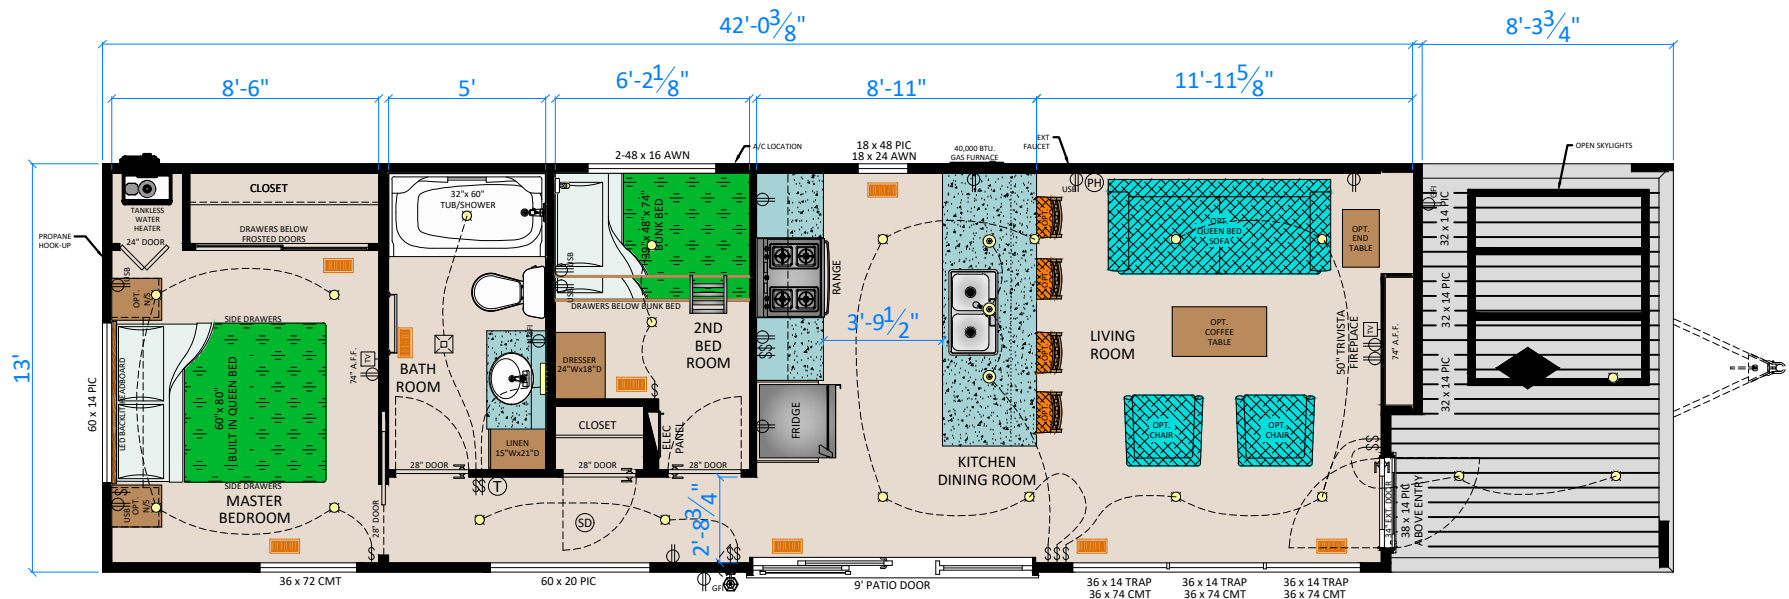

BDE 250-2 - 26 (4113)
(534 SQ.FT.)
STANDARD

ELECTRICAL LEGEND					
	LED POTLIGHT		SWITCH		TV RECEPTACLE
	PAN LIGHT		EXHAUST FAN		THERMOSTAT
	TRACK LIGHT		EXHAUST FAN WITH LIGHT		FURNACE SWITCH
	COACH LIGHT		RECEPTACLE		WATER HEATER SWITCH
	PENDANT LIGHT		RECEPTACLE W/ USB		AIR CONDITIONER/ FIREPLACE SWITCH
	VANITY LIGHT		GFI RECEPTACLE		PHONE JACK
	READING LIGHT		FLOOR RECEPTACLE		SMOKE DETECTOR

THE ATTACHED PLANS ARE THE PROPERTY OF AND FOR THE EXCLUSIVE USE OF GENERAL COACH CANADA. THE DESIGNS OR PORTION THEREOF MAY NOT BE COPIED OR OTHERWISE USED IN ANY WAY WITHOUT OUR WRITTEN CONSENT. UNAUTHORIZED USE OF THE PLANS IS STRICTLY FORBIDDEN.

THE ATTACHED PLANS ARE BUILT IN ACCORDANCE TO CAN/CSA Z241 PM

MODEL YEAR:	2026	PRINT DATE:	11/29/2024 9:47 AM
BDE		DRAWN BY:	J. SEATON