


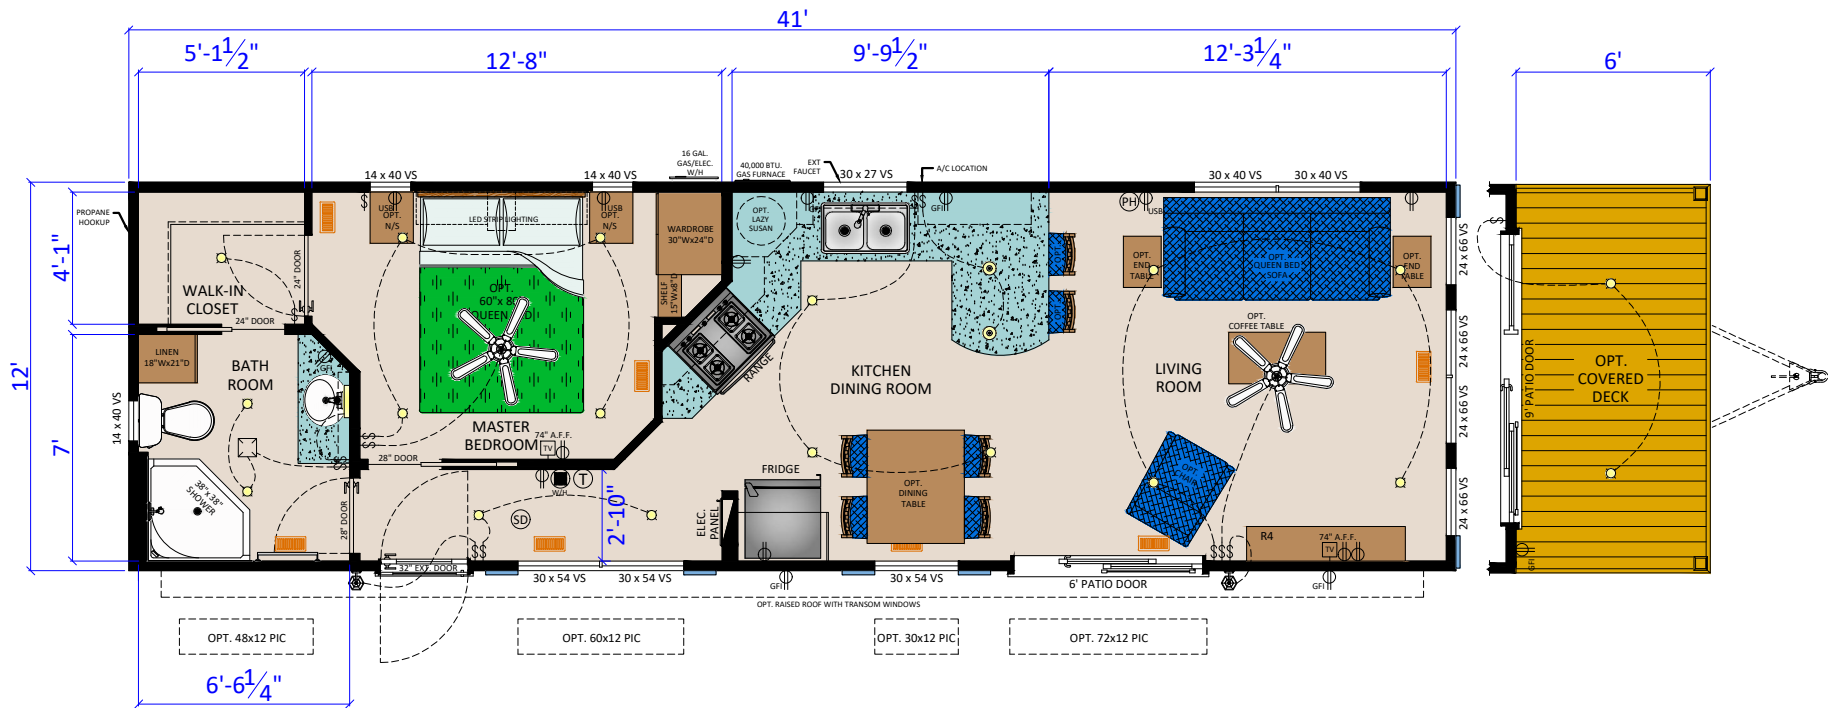

RADISSON 25 (R4012 1BR)
(492 SQ.FT.)
STANDARD

ELECTRICAL LEGEND					
	LED POTLIGHT		SWITCH		TV RECEPTACLE
	DOME LIGHT		FAN		THERMOSTAT
	TRACK LIGHT		FAN WITH LIGHT		FURNACE SWITCH
	COACH LIGHT		RECEPTACLE		WATER HEATER SWITCH
	PENDANT LIGHT		RECEPTACLE W/ USB		AIR CONDITIONER/FIREPLACE SWITCH
	VANITY LIGHT		GFI RECEPTACLE		PHONE JACK
	READING LIGHT		FLOOR RECEPTACLE		SMOKE DETECTOR

THE ATTACHED PLANS ARE THE PROPERTY AND FOR THE EXCLUSIVE USE OF GENERAL COACH CANADA. THE DESIGNS OR PORTION THEREOF MAY NOT BE COPIED OR OTHERWISE USED IN ANY WAY WITHOUT OUR WRITTEN CONSENT. UNAUTHORIZED USE OF THE PLANS IS STRICTLY FORBIDDEN.		THE ATTACHED PLANS ARE BUILT IN ACCORDANCE TO CAN/CSA 2241 PM	
		MODEL YEAR:	PRINT DATE:
		2025	10/15/2024 8:24 AM
DRAWN BY:		J. SEATON	