


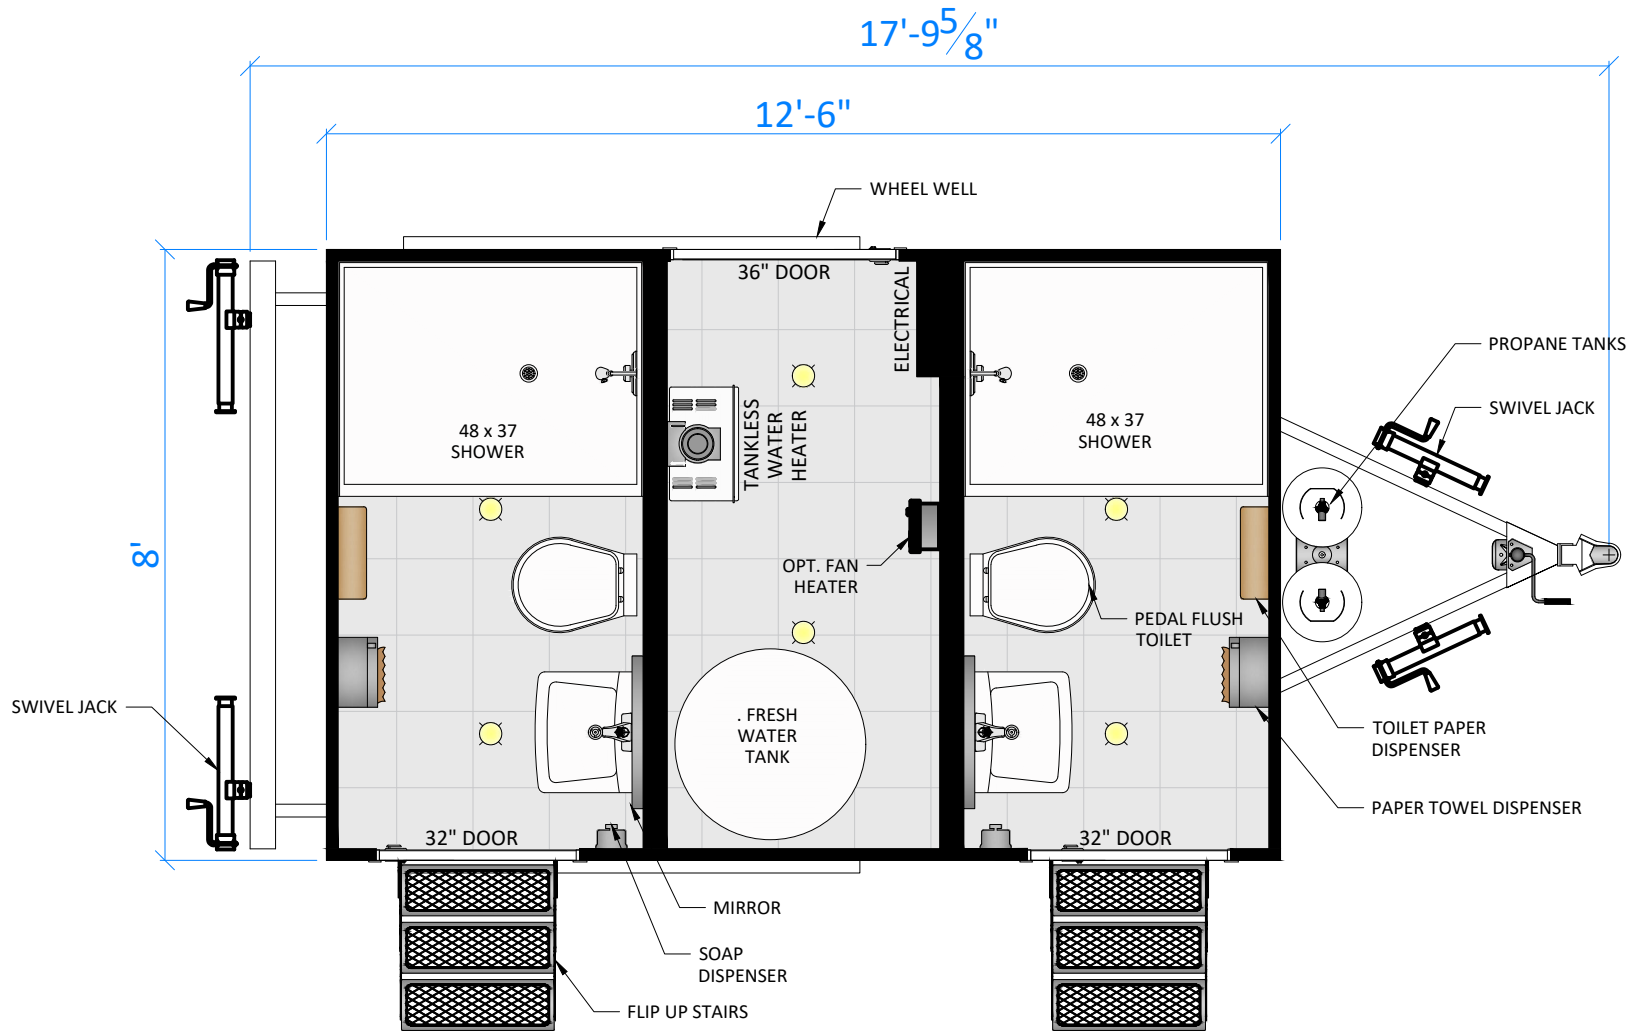

LUNAR MOON COLLECTION LM128-PC2

ELECTRICAL LEGEND

	LED POTLIGHT		SWITCH		TV RECEPTACLE
	DOMELIGHT		FAN		THERMOSTAT
	TRACK LIGHT		FAN WITH LIGHT		FURNACE SWITCH
	COACH LIGHT		RECEPTACLE		WATER HEATER SWITCH
	PENDANT LIGHT		RECEPTACLE W/ USB		AIR CONDITIONER/FIREPLACE SWITCH
	VANITY LIGHT		GFI RECEPTACLE		PHONE JACK
	READING LIGHT		FLOOR RECEPTACLE		SMOKE DETECTOR

MODEL YEAR:	PRINT DATE:
2026	2/24/2026 2:51 PM
DRAWN BY:	