


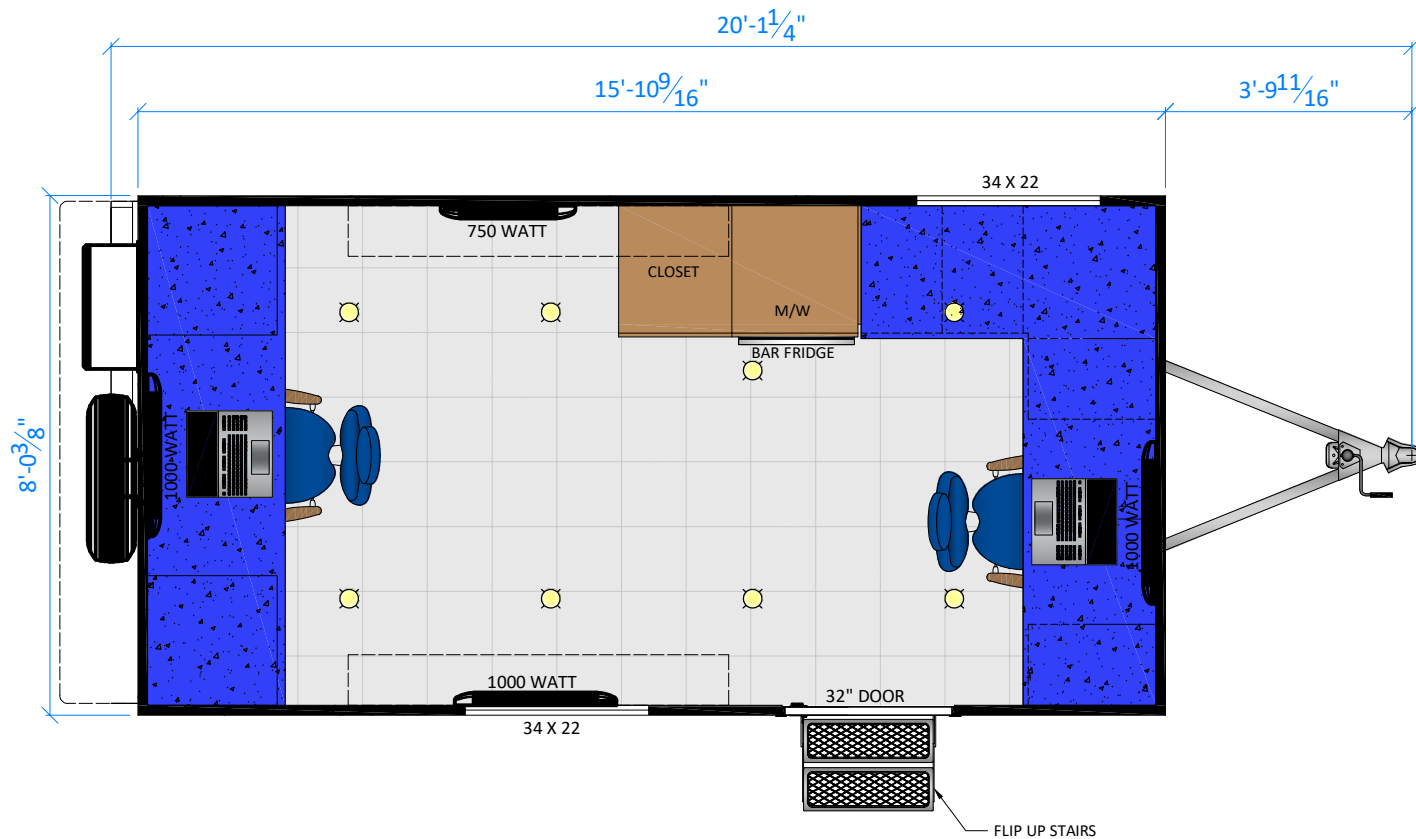

WORKSITE OFFICE TRAILER WOT 168 128 SQ.FT.

ELECTRICAL LEGEND

	LED POTLIGHT		SWITCH		TV RECEPTACLE
	DOME LIGHT		FAN		THERMOSTAT
	TRACK LIGHT		FAN WITH LIGHT		FURNACE SWITCH
	COACH LIGHT		RECEPTACLE		WATER HEATER SWITCH
	PENDANT LIGHT		RECEPTACLE W/ USB		AIR CONDITIONER/FIREPLACE SWITCH
	VANITY LIGHT		GFI RECEPTACLE		PHONE JACK
	READING LIGHT		FLOOR RECEPTACLE		SMOKE DETECTOR

		MODEL YEAR: 2025 PRINT DATE: 3/5/2025 9:37 AM		DRAWN BY:
FILENAME & PATH: D:\Vault Workspace\Designs\20 PLANS\2025\TRAVEL DIVISION\OFFICES\2025 Worksite Office Trailers.dwg				